



FOUNDATION SCHEDULE	
NUMBER	TYPE
1	115KV VT/LA STAND
2	115KV SWITCH
3	115KV CIRCUIT BREAKER
4	115KV DISCONNECT SWITCH
5	115KV LA/VT STAND
6	115KV DISCONNECT SWITCH
7	115 KV BUS SUPPORT
8	CONTROL HOUSE PIER FOUNDATION
9	FIBER OPTIC BUILDING FOUNDATION

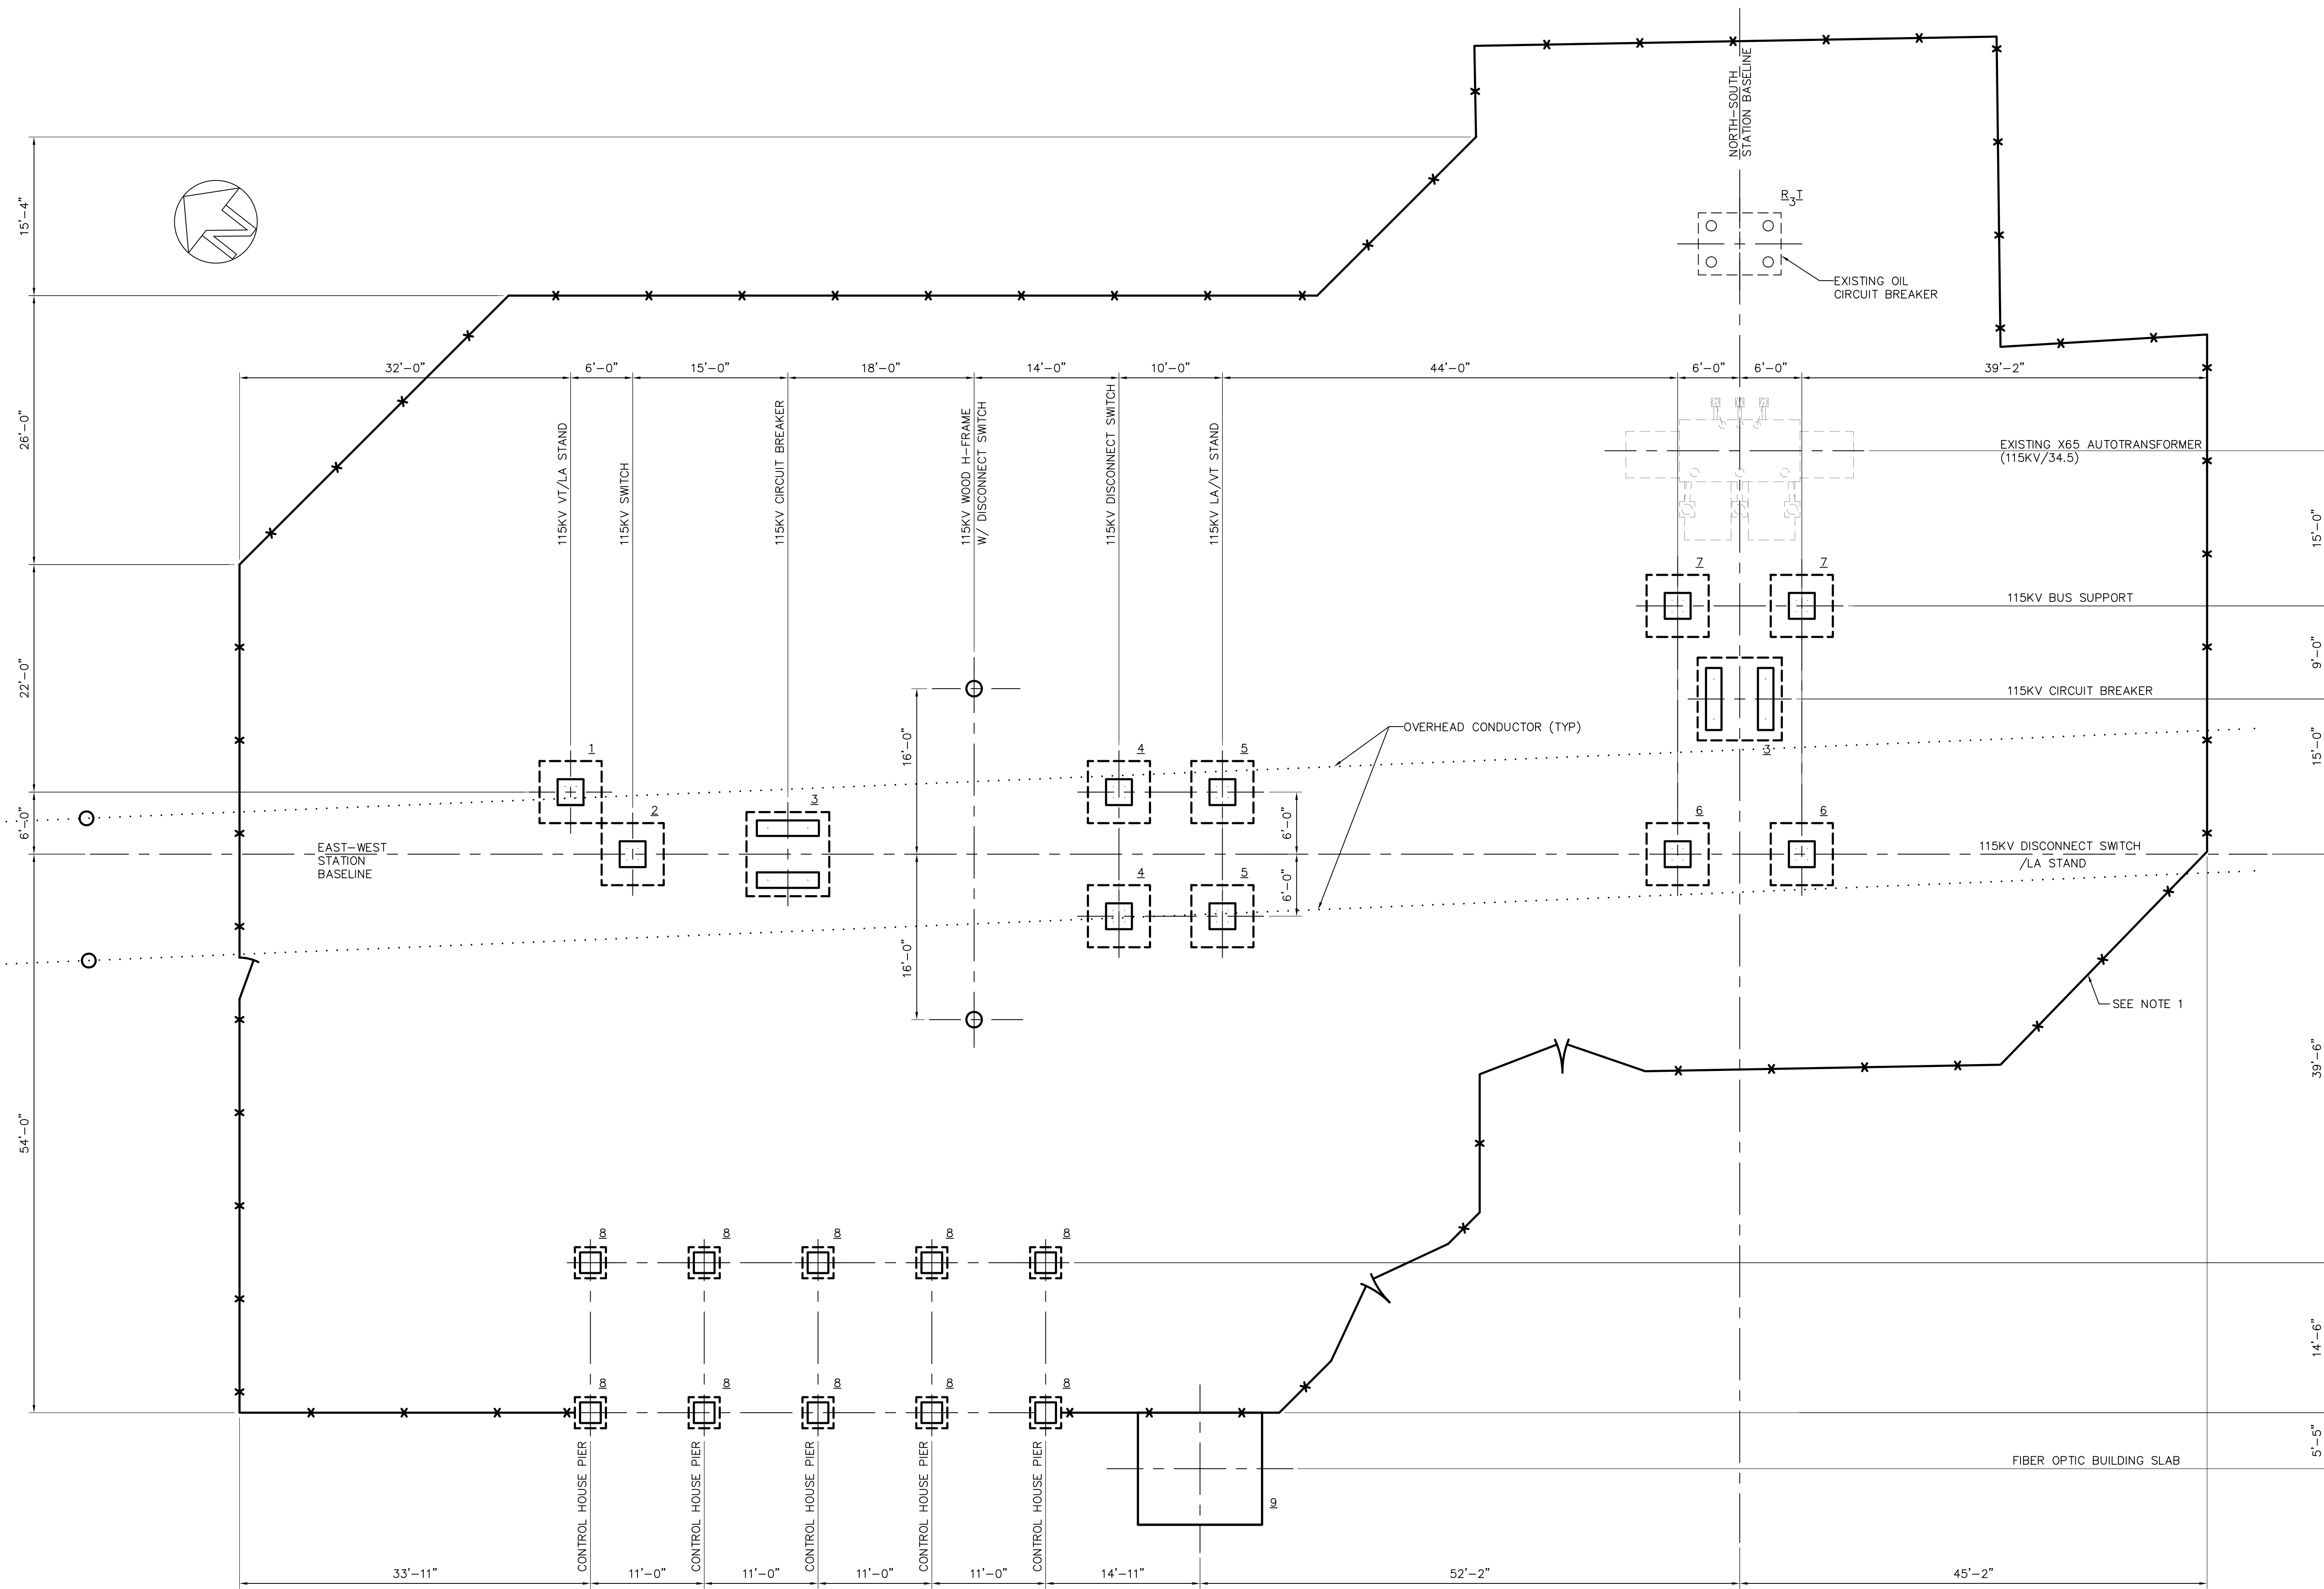

FOUNDATION PLAN
SCALE: 1/8"=1'-0"

NOTE:
1. REPLACE ENTIRE FENCE WITH 7' FENCE.

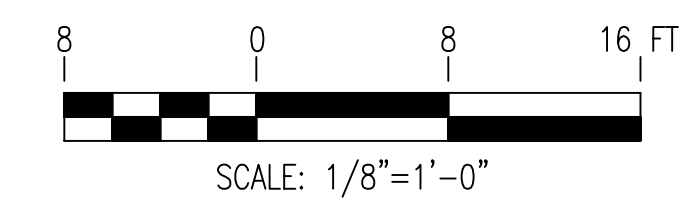

NOTE:
THIS DRAWING IS FOR CONCEPTUAL PURPOSES ONLY.

PRELIMINARY
NOT FOR CONSTRUCTION

C	7/27/06	PEI	PEI	ISSUED FOR PERMIT
B	7/5/06	EVD	PSK	ISSUED FOR PERMIT
A	6/15/06	EVD	PSK	ISSUED FOR CLIENT REVIEW
REV	DATE	DR	CK	DESCRIPTION
VILCO VERMONT ELECTRIC POWER CO., INC. RUTLAND, VERMONT MIDDLESEX SUBSTATION				
FOUNDATION PLAN 115 kV YARD MORETOWN, VERMONT				
SCALE:	AS NOTED	DRAWN BY:	PEI	APPROVED BY:
DATE:	6/15/06	CHECKED BY:	PEI	DATE:
DRAWING NUMBER:	209-6040D			1
PLOT:	1=1	REV.		



108 LAFAYETTE ST
YARMOUTH, ME 04096
www.powereng.com

THIS DRAWING WAS PREPARED BY POWER ENGINEERS, INC. FOR A SPECIFIC PROJECT. IT IS NOT TO BE USED FOR ANY OTHER PROJECT WITHOUT THE WRITTEN PERMISSION OF POWER ENGINEERS, INC. THE USER ASSUMES ALL LIABILITY FOR ANY ERRORS OR OMISSIONS IN THIS DRAWING. POWER ENGINEERS, INC. IS NOT RESPONSIBLE FOR ANY DAMAGE TO PERSONS OR PROPERTY CAUSED BY THE USE OF THIS DRAWING.

PROJECT NO.: 110279
CONTRACT NO.: XXXXXX

FILE NAME:

2096040D

FILE: 2096040D.DWG